


CONTRACTOR MUST VERIFY ALL DIMENSIONS ON THE JOB BEFORE COMMENCING ANY WORK OR MAKING ANY SHOP DRAWINGS.

LEGEND
 r.w.p. rainwater pipe
 i.o. inspection opening
 ○ light point
 —x— switch & wire

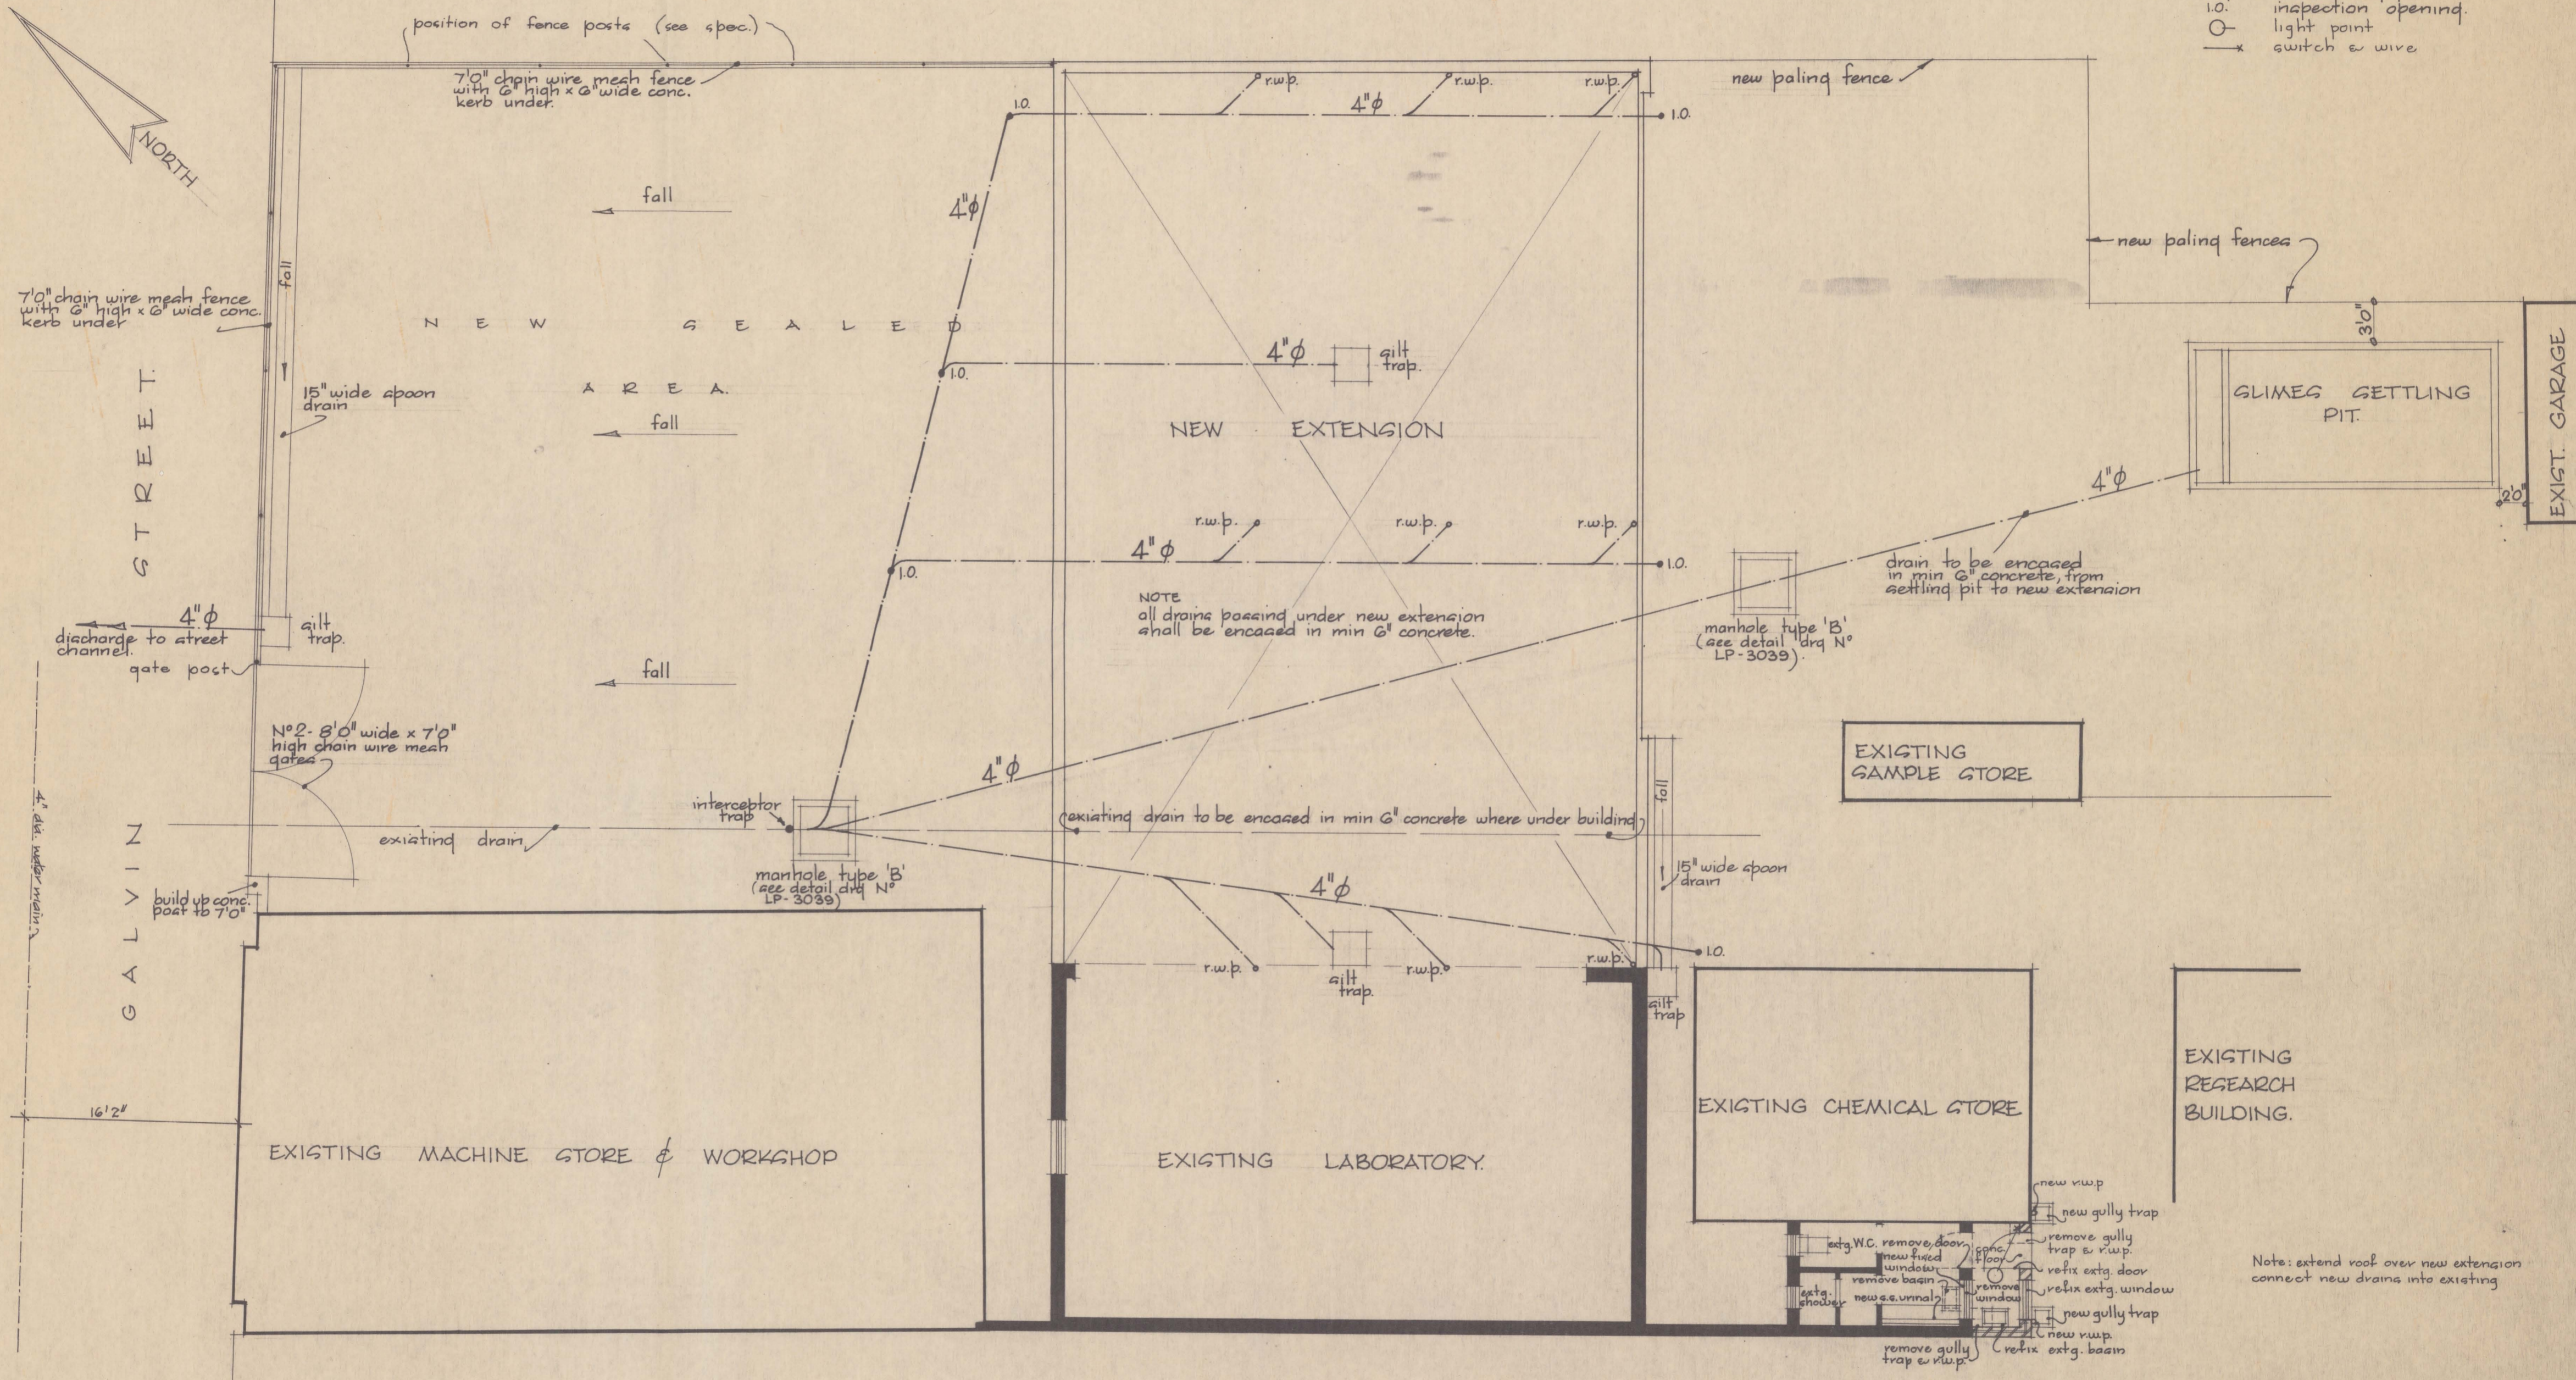

DEPARTMENT OF PUBLIC WORKS - TASMANIA

MINEG DEPARTMENT-LAUNCESTON - LABORATORY EXTENSIONS

SCALES - 8'0" = 1" DRAWN - G.C.H.

Geo. Underwood TRACED -
 DISTRICT ARCHITECT

EXAMINED -
 DATE - 14-12-62

GITE PLAN (DRAINAGE LAYOUT)
 DRAWING No. -
LC-3617

C. D. ROSE, CHIEF ARCHITECT

